


REVISION	NO.
CITY COMMENTS	J

HOLIDAY INN EXPRESS
 850 NORTHSIDE DRIVE
 PILOT POINT, TEXAS 76258

LOCATION
 91024

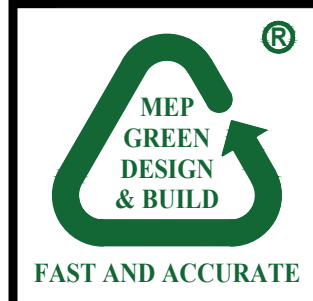

FAST AND ACCURATE
 JAN. 05, 2024

 JUNG DUC VU
 193111
 MEP GREEN DESIGN & BUILD, P.L.C.
 REGISTRATION # F-10992
 915 GEMIN ST, HOUSTON, TX 77068
 TEL: (281)-785-1155
 FAX: (281)-282-9144
 WWW.MEPGREENDESIGNS.COM


RSS architects llc
 RSS-ARCHITECTS.COM
 817/538-9258

Date 01-08-2024
 Job 22020

Sheet
FA2.0

Reviewed for Code Compliance
2015 IBC, IMC, IPC 2017 NEC 2015 IECC
Zac Loiseau I-2642
Subject to Field Inspections

SPRINKLER FLOW AND TAMPER SWITCH. PROVIDE ONE FLOW AND ONE TAMPER SWITCH FOR EACH SPRINKLER ZONE. FIELD COORDINATE QUANTITIES REQUIRED WITH SPRINKLER CONTRACTOR

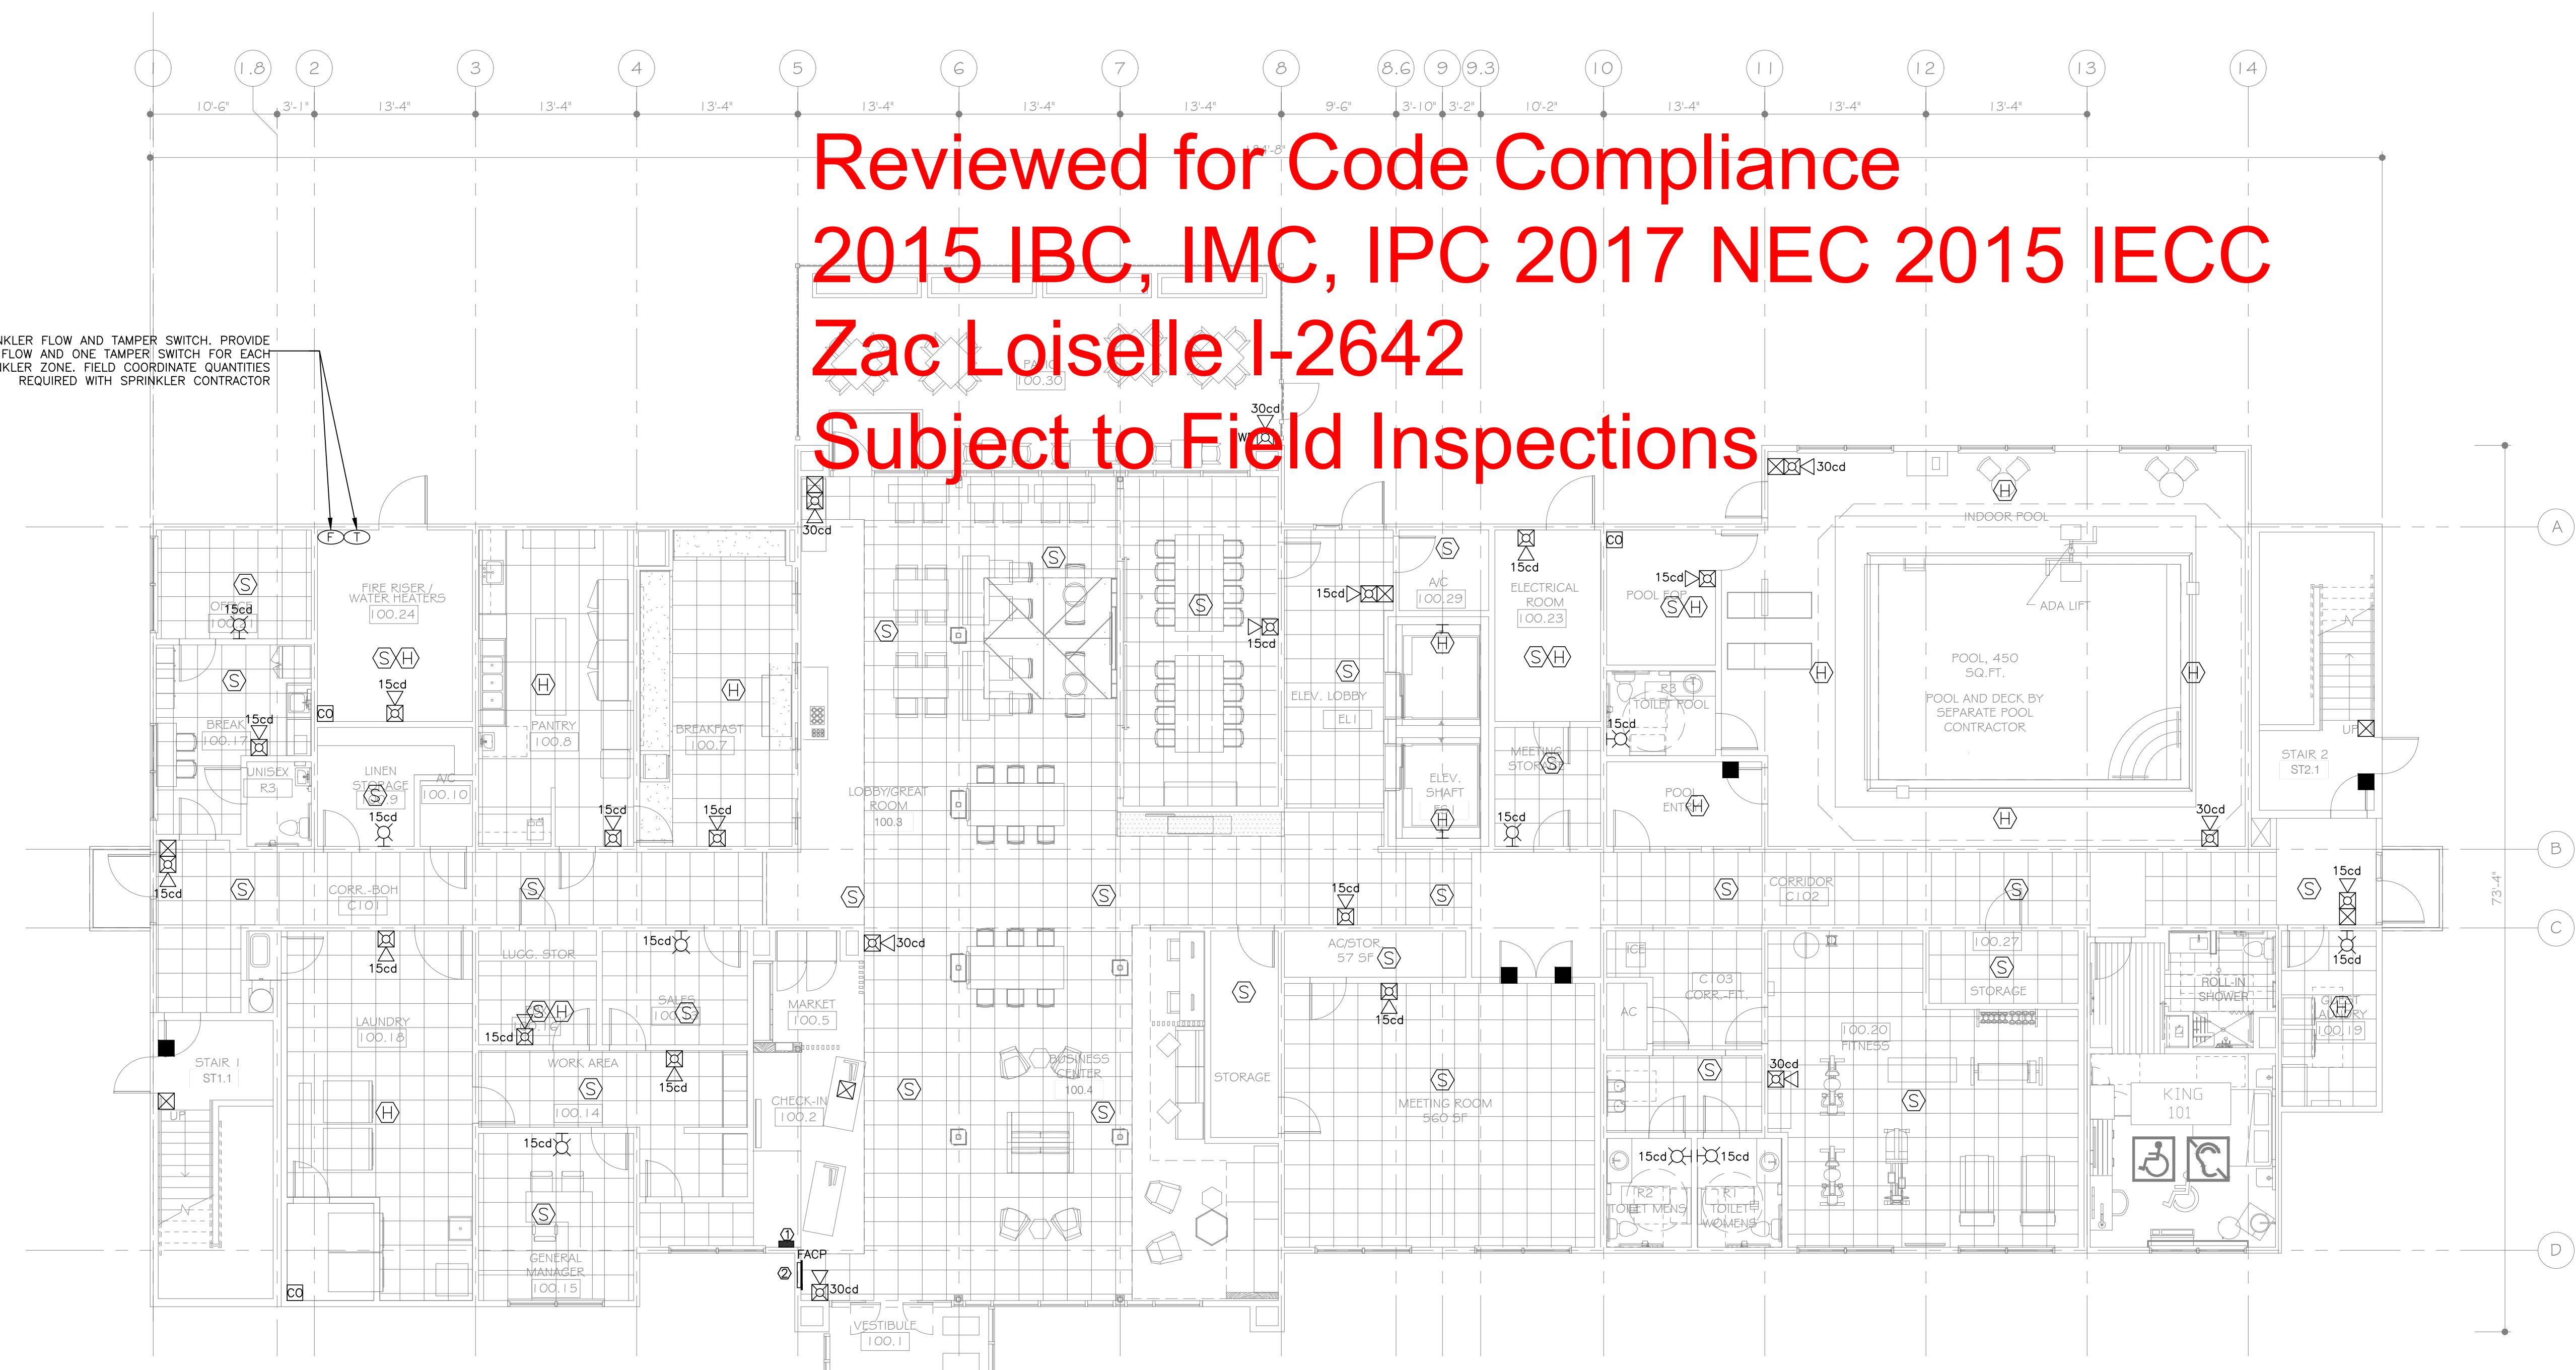

FIRE ALARM SYMBOL LIST		
SYMB.	DESCRIPTION	MOUNTING OR AS INDICATED
☒	FIRE ALARM MANUAL PULL STATION	WALL - 48" AFF
☒☒	ANNUNCIATOR AUDIO/VISUAL (HORN/STROBE)	WALL - 6"-8" AFF
☒☒	COMBINATION HORN/STROBE LIGHT	WALL - 6"-8" AFF
☒☒	STROBE LIGHT	WALL - 6"-8" AFF
☐	FIRE BELL	WALL
☐	SMOKE DETECTOR	CEILING
☐	DUCT DETECTOR	IN MECH. DUCT
☐	HEAT DETECTOR	CEILING
☐	MAGNETIC DOOR HOLDER	WALL
☐	SPECIAL DEVICE (AS NOTED)	
☐	SHUT DOWN RELAY	
☐	FLOW SWITCH (SPRINKLER)	
☐	TAMPER SWITCH (SPRINKLER)	
☐	SMOKE DETECTOR	WALL
☐	CARBON MONOXIDE DETECTOR	
☐	FIREMAN'S PHONE	WALL - 48" AFF.
☐	2-WAY COMMUNICATION DEVICE	WALL - 48" AFF.
☐	ANNUNCIATOR PANEL	
☐	FIRE ALARM CONTROL PANEL (FACP)	
☐	INDICATES HANDICAP ACCESS SUITE	
☐	INDICATES HEARING IMPAIRED SUITE	

NOTE FOR FIRE ALARM SYSTEM:
 1. FIRE ALARM SYSTEM SHALL BE SEPARATELY PERMITTED AND SUBMITTED BY THE FIRE ALARM CONTRACTOR.

- KEY NOTES:**
1. LOCATION OF CENTRAL CONTROL POINT FOR 2-WAYS COMMUNICATION SYSTEM
 2. VERIFY LOCATION OF FACP WITH FIRE MARSHAL PRIOR TO INSTALLATION

1 FIRE ALARM FIRST FLOOR PLAN
 SCALE: 1/8"=1'-0"

MEP GREEN DESIGN & BUILD, P.L.C. RETAINS COPYRIGHT TO THIS DOCUMENT. THE IDEA DESIGN AND DETAILS, AS A PROFESSIONAL AND INTELLECTUAL INSTRUMENT OF SERVICE, AND IS NOT TO BE USED/COPIED IN WHOLE OR IN PART, FOR ANY OTHER PROJECT WITHOUT THE EXPRESSED WRITTEN CONSENT OF MEP GREEN DESIGN & BUILD, P.L.C.