


**Reviewed for Code Compliance**  
**2015 IBC, IMC, IPC 2017 NEC 2015 IECC**  
**Zac Loiselle I-2642**  
**Subject to Field Inspections**

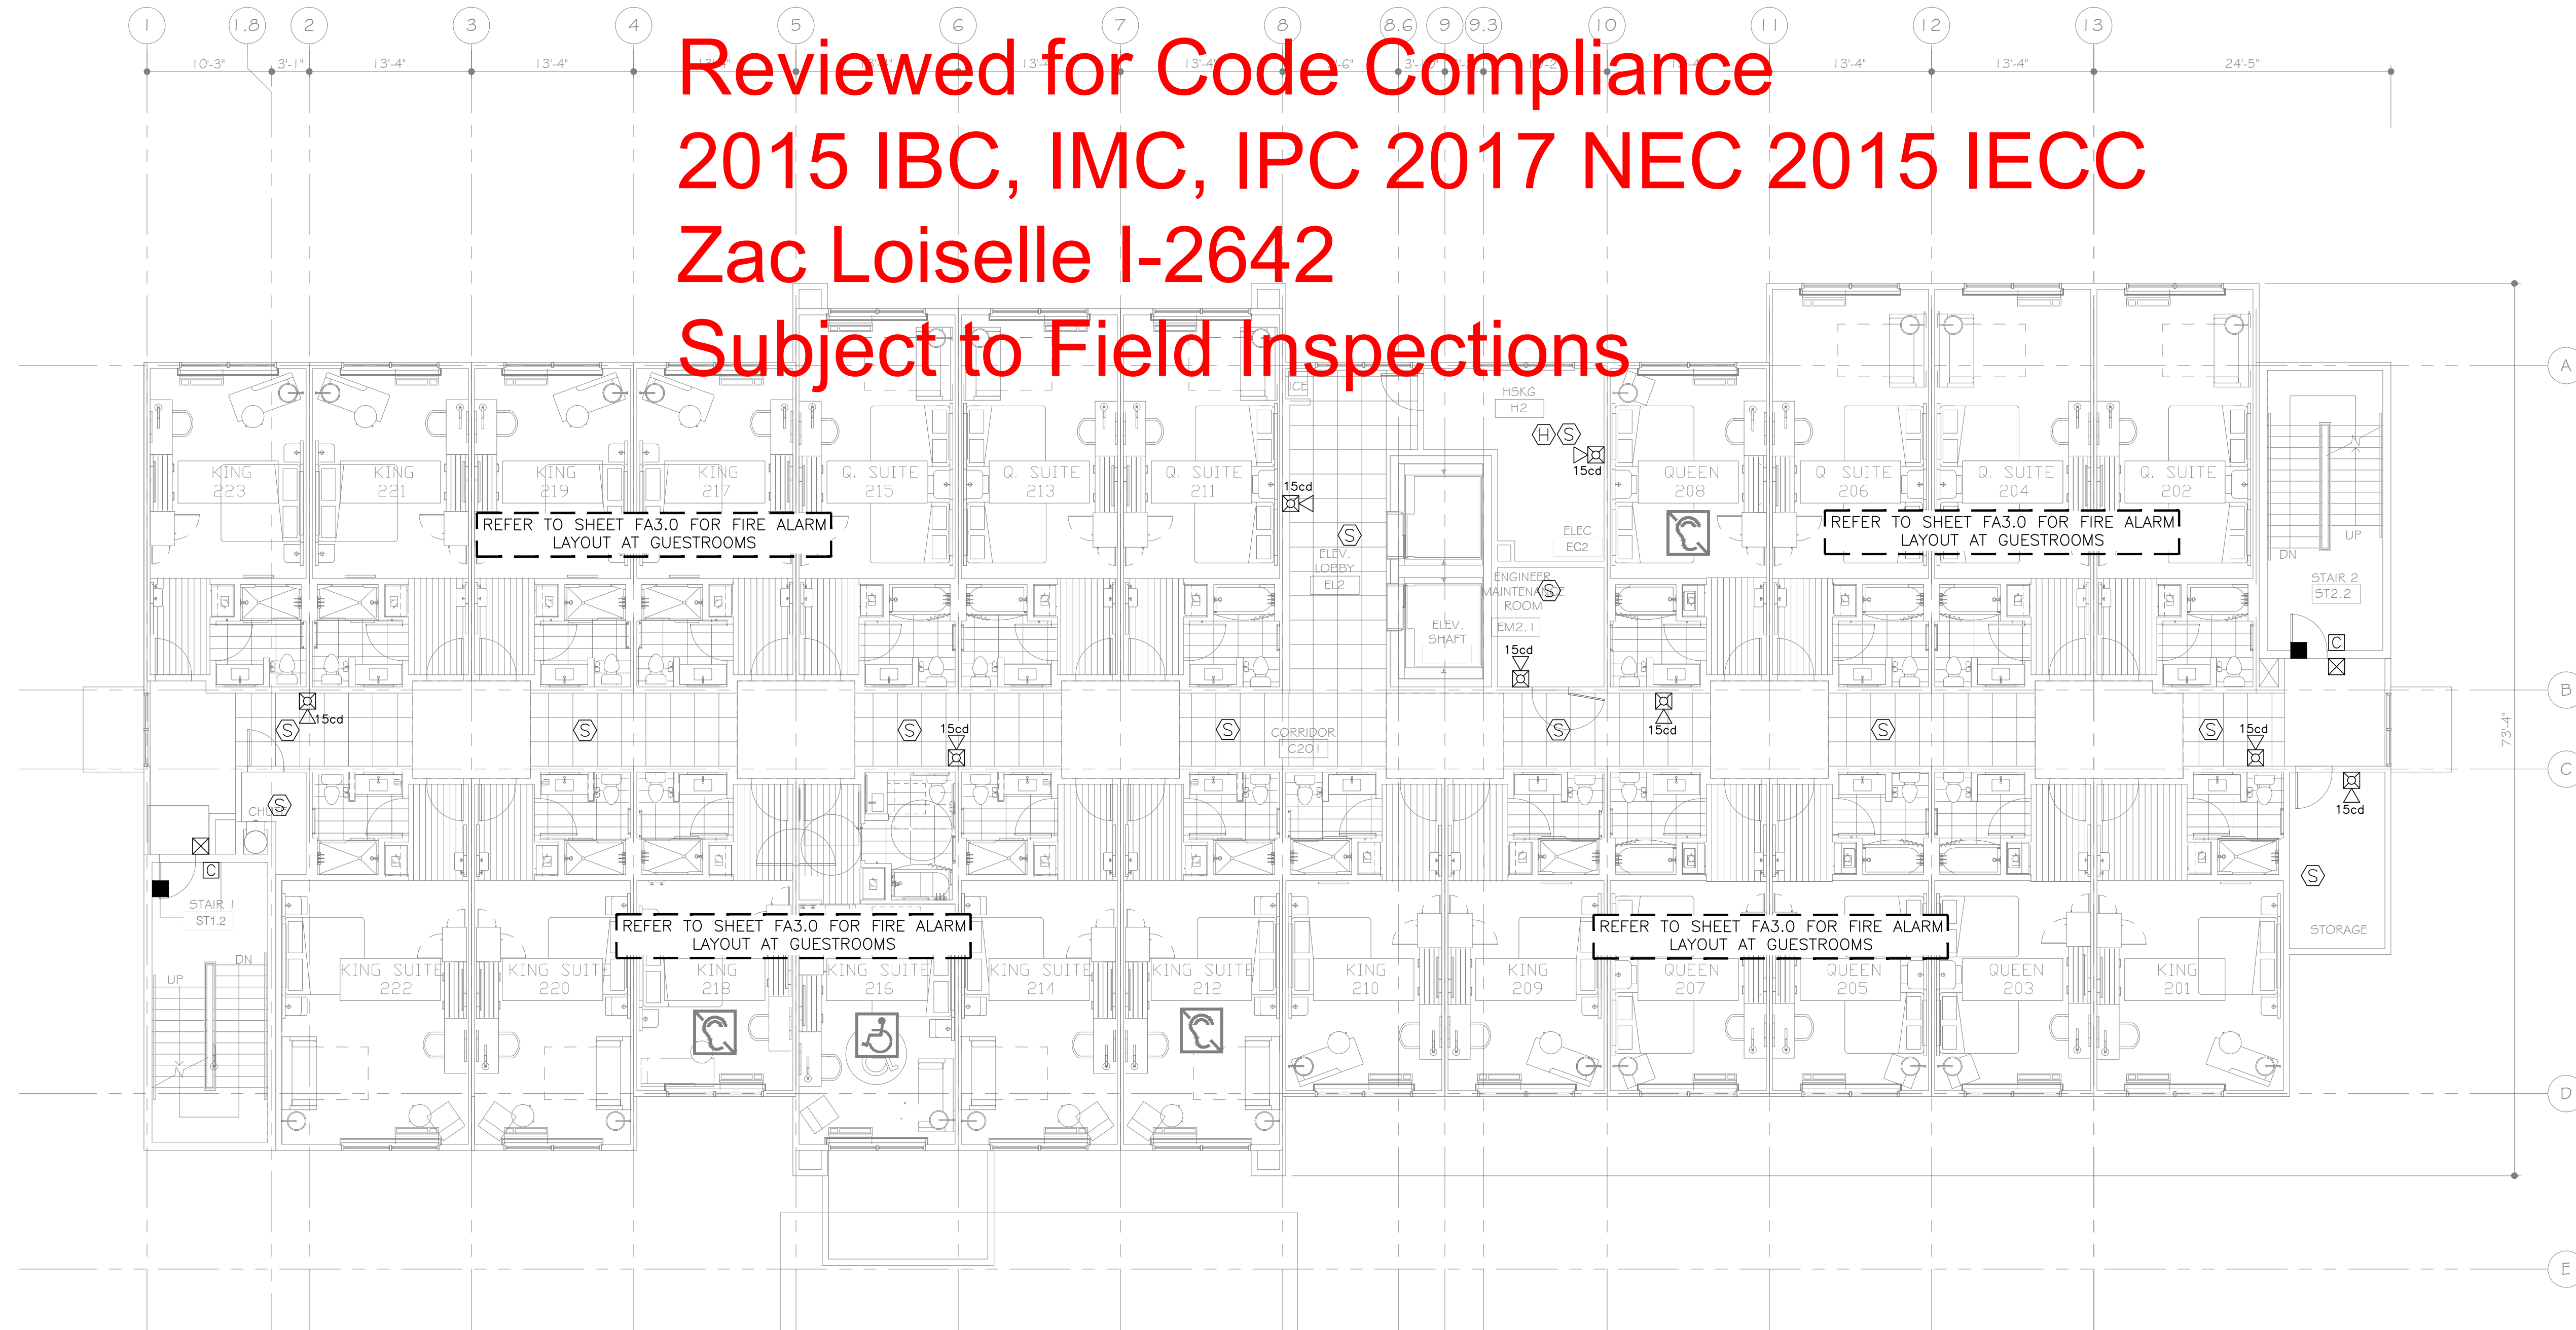

FIRE ALARM SYMBOL LIST		
SYMB.	DESCRIPTION	MOUNTING OR AS INDICATED
☐	FIRE ALARM MANUAL PULL STATION	WALL - 48" AFF
☐	ANNUNCIATOR AUDIO/VISUAL (HORN/STROBE)	WALL - 6'-8" AFF
☐	COMBINATION HORN/STROBE LIGHT	WALL - 6'-8" AFF
☐	STROBE LIGHT	WALL - 6'-8" AFF
☐	FIRE BELL	WALL
☐	SMOKE DETECTOR	CEILING
☐	DUCT DETECTOR	IN MECH. DUCT
☐	HEAT DETECTOR	CEILING
☐	MAGNETIC DOOR HOLDER	WALL
☐	SPECIAL DEVICE (AS NOTED)	
☐	SHUT DOWN RELAY	
☐	FLOW SWITCH (SPRINKLER)	
☐	TAMPER SWITCH (SPRINKLER)	
☐	SMOKE DETECTOR	WALL
☐	CARBON MONOXIDE DETECTOR	
☐	FIREMAN'S PHONE	WALL - 48" AFF.
☐	2-WAY COMMUNICATION DEVICE	WALL - 48" AFF.
☐	ANNUNCIATOR PANEL	
☐	FIRE ALARM CONTROL PANEL (FACP)	
☐	INDICATES HANDICAP ACCESS SUITE	
☐	INDICATES HEARING IMPAIRED SUITE	

**NOTE FOR FIRE ALARM SYSTEM:**

- FIRE ALARM SYSTEM SHALL BE SEPARATELY PERMITTED AND SUBMITTED BY THE FIRE ALARM CONTRACTOR.

**1 FIRE ALARM SECOND FLOOR PLAN**  
 SCALE: 1/8"=1'-0"

MEP GREEN DESIGN & BUILD, P.L.L.C. RETAINS COPYRIGHT TO THIS DOCUMENT. THE IDEA DESIGN AND DETAILS, AS A PROFESSIONAL AND INTELLECTUAL INSTRUMENT OF SERVICE, AND IS NOT TO BE USED/COPIED IN WHOLE OR IN PART, FOR ANY OTHER PROJECT WITHOUT THE EXPRESSED WRITTEN CONSENT OF MEP GREEN DESIGN & BUILD, P.L.L.C.

REVISION	NO.
CITY COMMENTS	J
<b>HOLIDAY INN EXPRESS</b>	
850 NORTHSIDE DRIVE PILOT POINT, TEXAS 76258	
LOCATION 91024	
MEP GREEN DESIGN & BUILD, P.L.L.C. REGISTRATION # F-10692 915 GEDIN ST, HOUSTON, TX 77058 Tel: (281)-786-1155 Fax: (281)-282-9144 www.mepgreendesigns.com	
RSS-ARCHITECTS.COM 817/538-9258	
Date	01-08-2024
Job	22020
Sheet	<b>FA2.1</b>